

POWER & DATA LEGEND	
⊕	DUPLEX POWER OUTLET
⊕	DUPLEX DEDICATED POWER OUTLET
⊕	QUAD DEDICATED POWER OUTLET
⊕	FLOOR MOUNTED POWER OUTLET
▽	DATA/VOICE OUTLET
⊕	FLOOR MOUNTED DATA OUTLET
⊕	WALL MOUNTED POWER & DATA JUNCTION BOX.
⊕	TV DATA CONNECTION
⊕ _{40"}	NUMBER INDICATES MOUNTING HEIGHT

POWER & DATA FLOOR PLAN

Suite 340 / Avnetura Corporate Center I

1/8" = 1'-0"




PROJECT NO:	1709-12
DRAWN BY:	VS
DATE:	01/09/2019
SCALE:	AS NOTED
SHEET NO:	SK-7A



insight
design

2930 Northeast
2nd Court
Miami, Florida
33137
305.545.4964

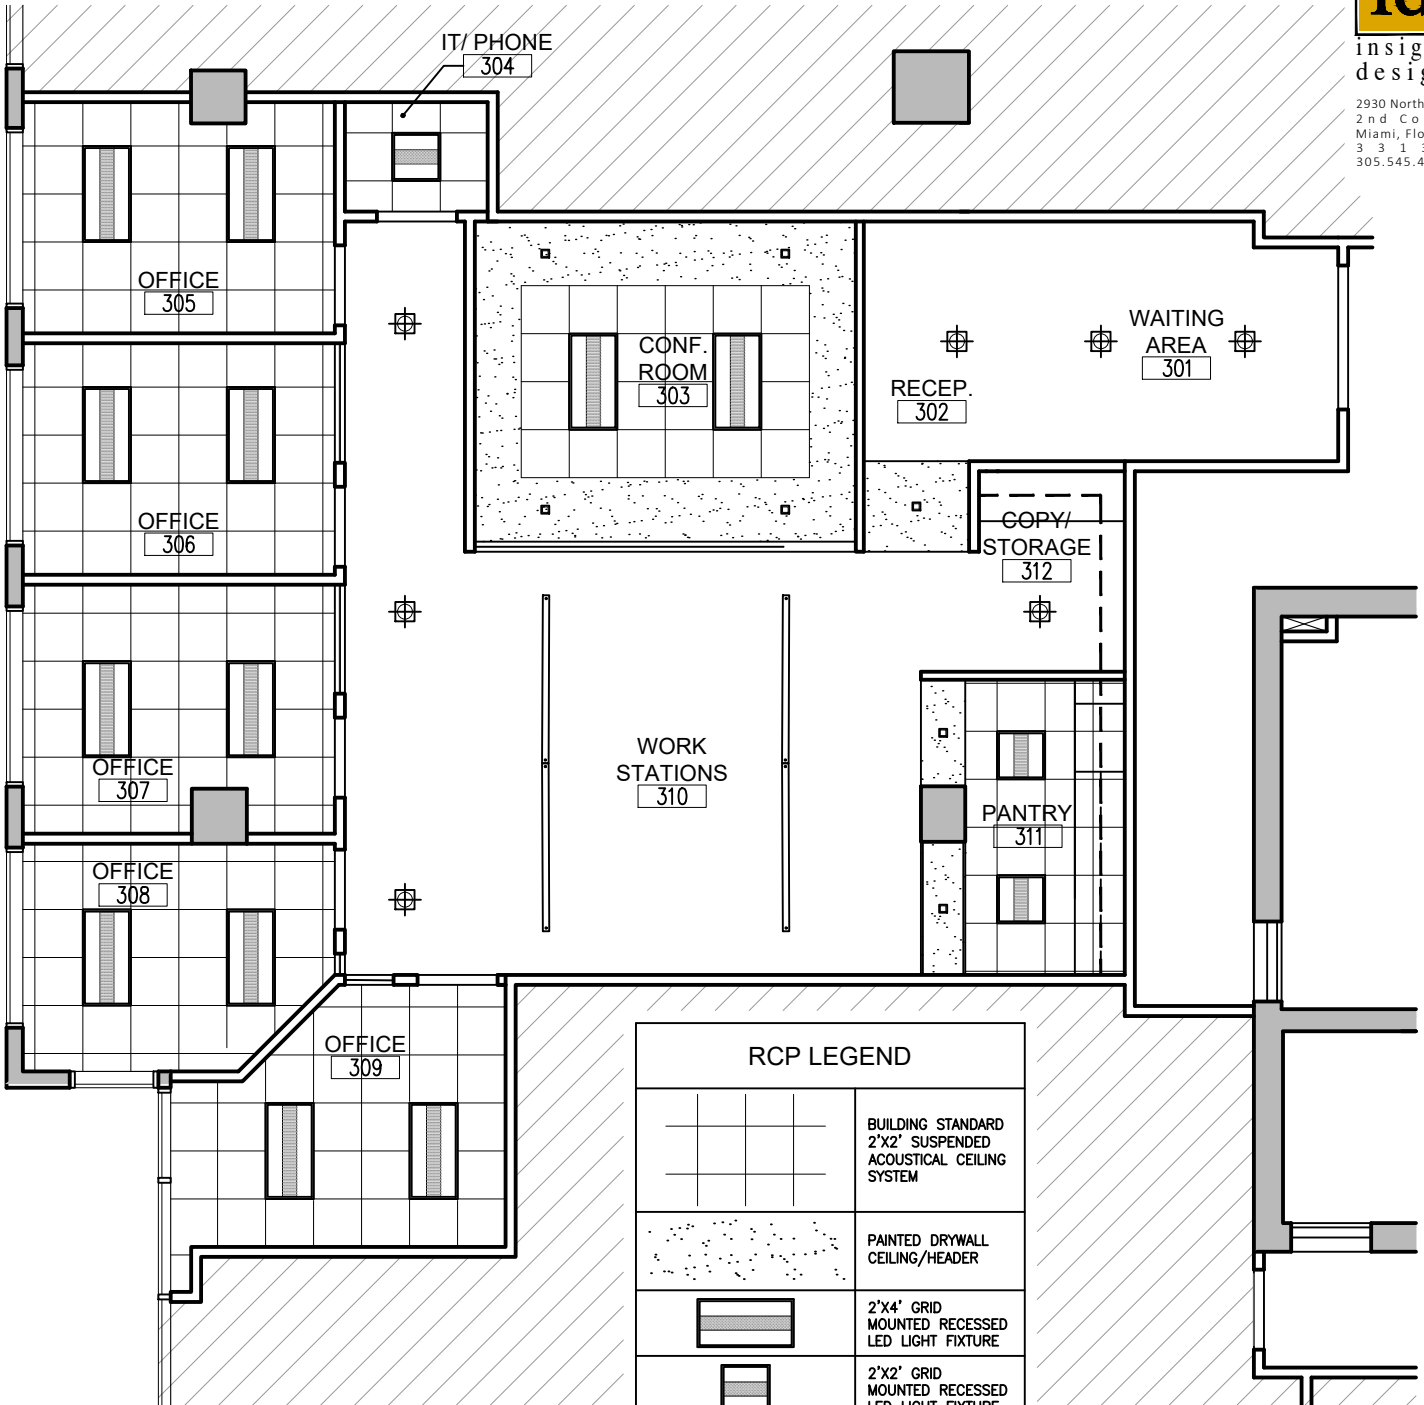

RCP LEGEND	
	BUILDING STANDARD 2'X2' SUSPENDED ACOUSTICAL CEILING SYSTEM
	PAINTED DRYWALL CEILING/HEADER
	2'X4' GRID MOUNTED RECESSED LED LIGHT FIXTURE
	2'X2' GRID MOUNTED RECESSED LED LIGHT FIXTURE
	4" LED SQUARE DOWNLIGHT
	PENDANT LIGHT FIXTURE
	PENDANT LINEAR LIGHT FIXTURE
	UNDER COUNTER LINEAR LIGHT FIXTURE

REFLECTED CEILING PLAN

Suite 340 / Avnetura Corporate Center I

1/8" = 1'-0"



PROJECT NO:	1709-12
DRAWN BY:	VS
DATE:	01/09/2019
SCALE:	AS NOTED
SHEET NO:	SK-7A