




insight
design

2930 Northeast
2nd Court
Miami, Florida
33137
305.545.4964

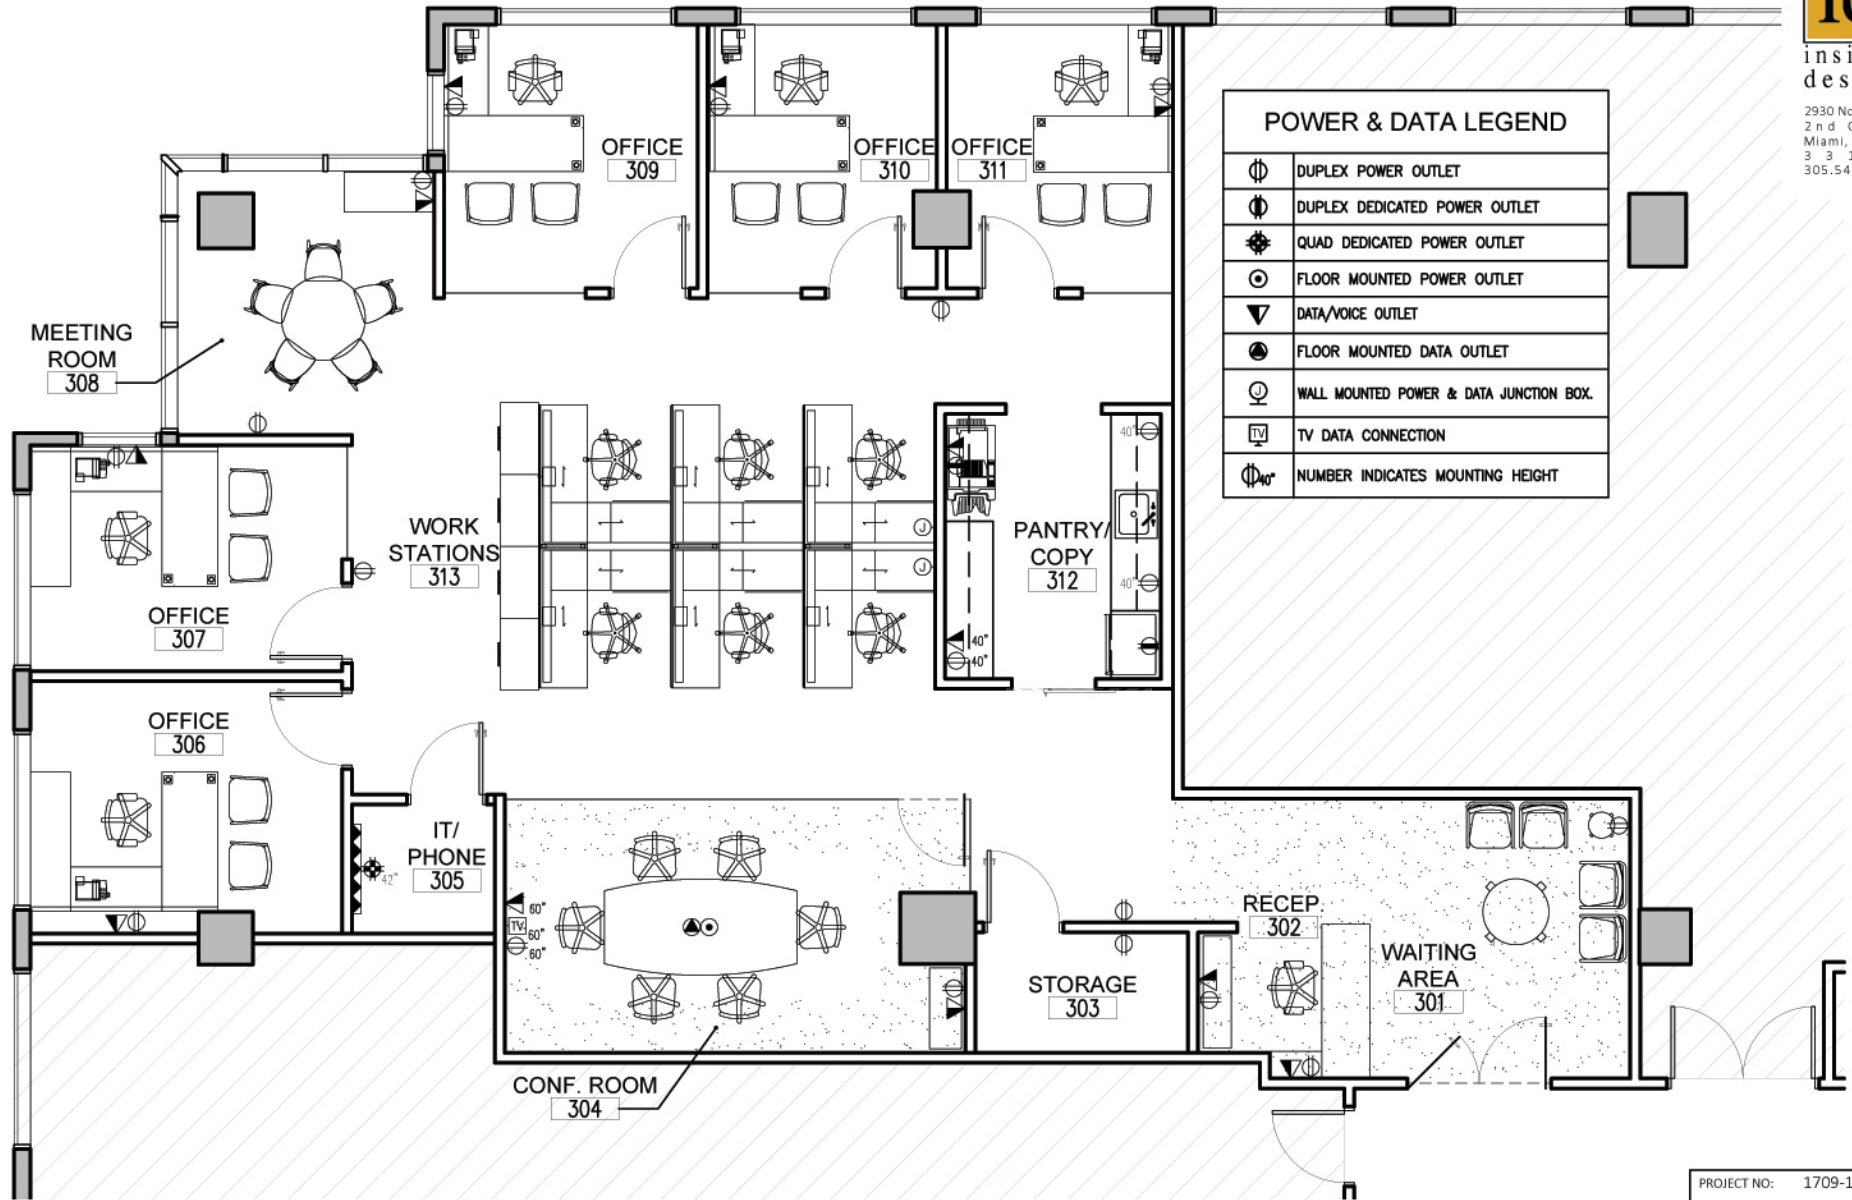

POWER & DATA FLOOR PLAN

Suite 330 / Avnetura Corporate Center I

1/8"=1'-0"



PROJECT NO:	1709-12
DRAWN BY:	VS
DATE:	01/09/2019
SCALE:	AS NOTED
SHEET NO:	SK-4A