


POWER AND COMMUNICATION LEGEND	
SYMBOL	DESCRIPTION
N	NEW DUPLEX OUTLET, 16" A.F.F.
N	NEW DUPLEX, G.F.I. OUTLET, 40" A.F.F.
E	EXISTING DUPLEX, 16" A.F.F.
N	NEW QUAD OUTLET LOCATION T.B.D.
E	EXISTING QUAD OUTLET TO REMAIN
N	NEW VOICE / DATA OUTLET, 16 A.F.F.
E	EXISTING VOICE / DATA OUTLET
N	NEW FLOOR MOUNTED POWER/DATA/TELEPHONE PORT AT CONFERENCE ROOM
N	NEW VOICE/DATA, TV AND POWER DUPLEX OUTLET @ 66" A.F.F., U.N.O.
N	NEW FLOOR MOUNTED JUNCTION BOX LOCATION TO BE COORDINATED BETWEEN GC AND FURNITURE INSTALLER
N	NEW TELEPHONE BOARD MOUNTED OVER FIRE-RATED PLYWOOD
ABBREVIATIONS:	
(A.F.F)	ABOVE FINISH FLOOR
(D)	DEDICATED OUTLET
G.F.I.	GROUND FAULT INTERRUPTOR
(AC)	ABOVE COUNTER
N.I.C.	NOT IN CONTRACT
TYP.	TYPICAL
T.B.D.	TO BE DETERMINED

ARCHITECTURAL LEGEND	
	EXISTING WALL/STRUCTURE/NON-LOAD BEARING DEMISING WALL TO REMAIN, U.N.O.
	NEW WALL PARTITION 6" ABOVE FINISH CEILING
	EXISTING STRUCTURE/COLUMN TO REMAIN
	HATCHED AREA DENOTES NOT INCLUDED IN CONTRACT, OUTSIDE OF SCOPE OF WORK
ROOM NAME 000	DENOTES ROOM NAME AND NUMBER

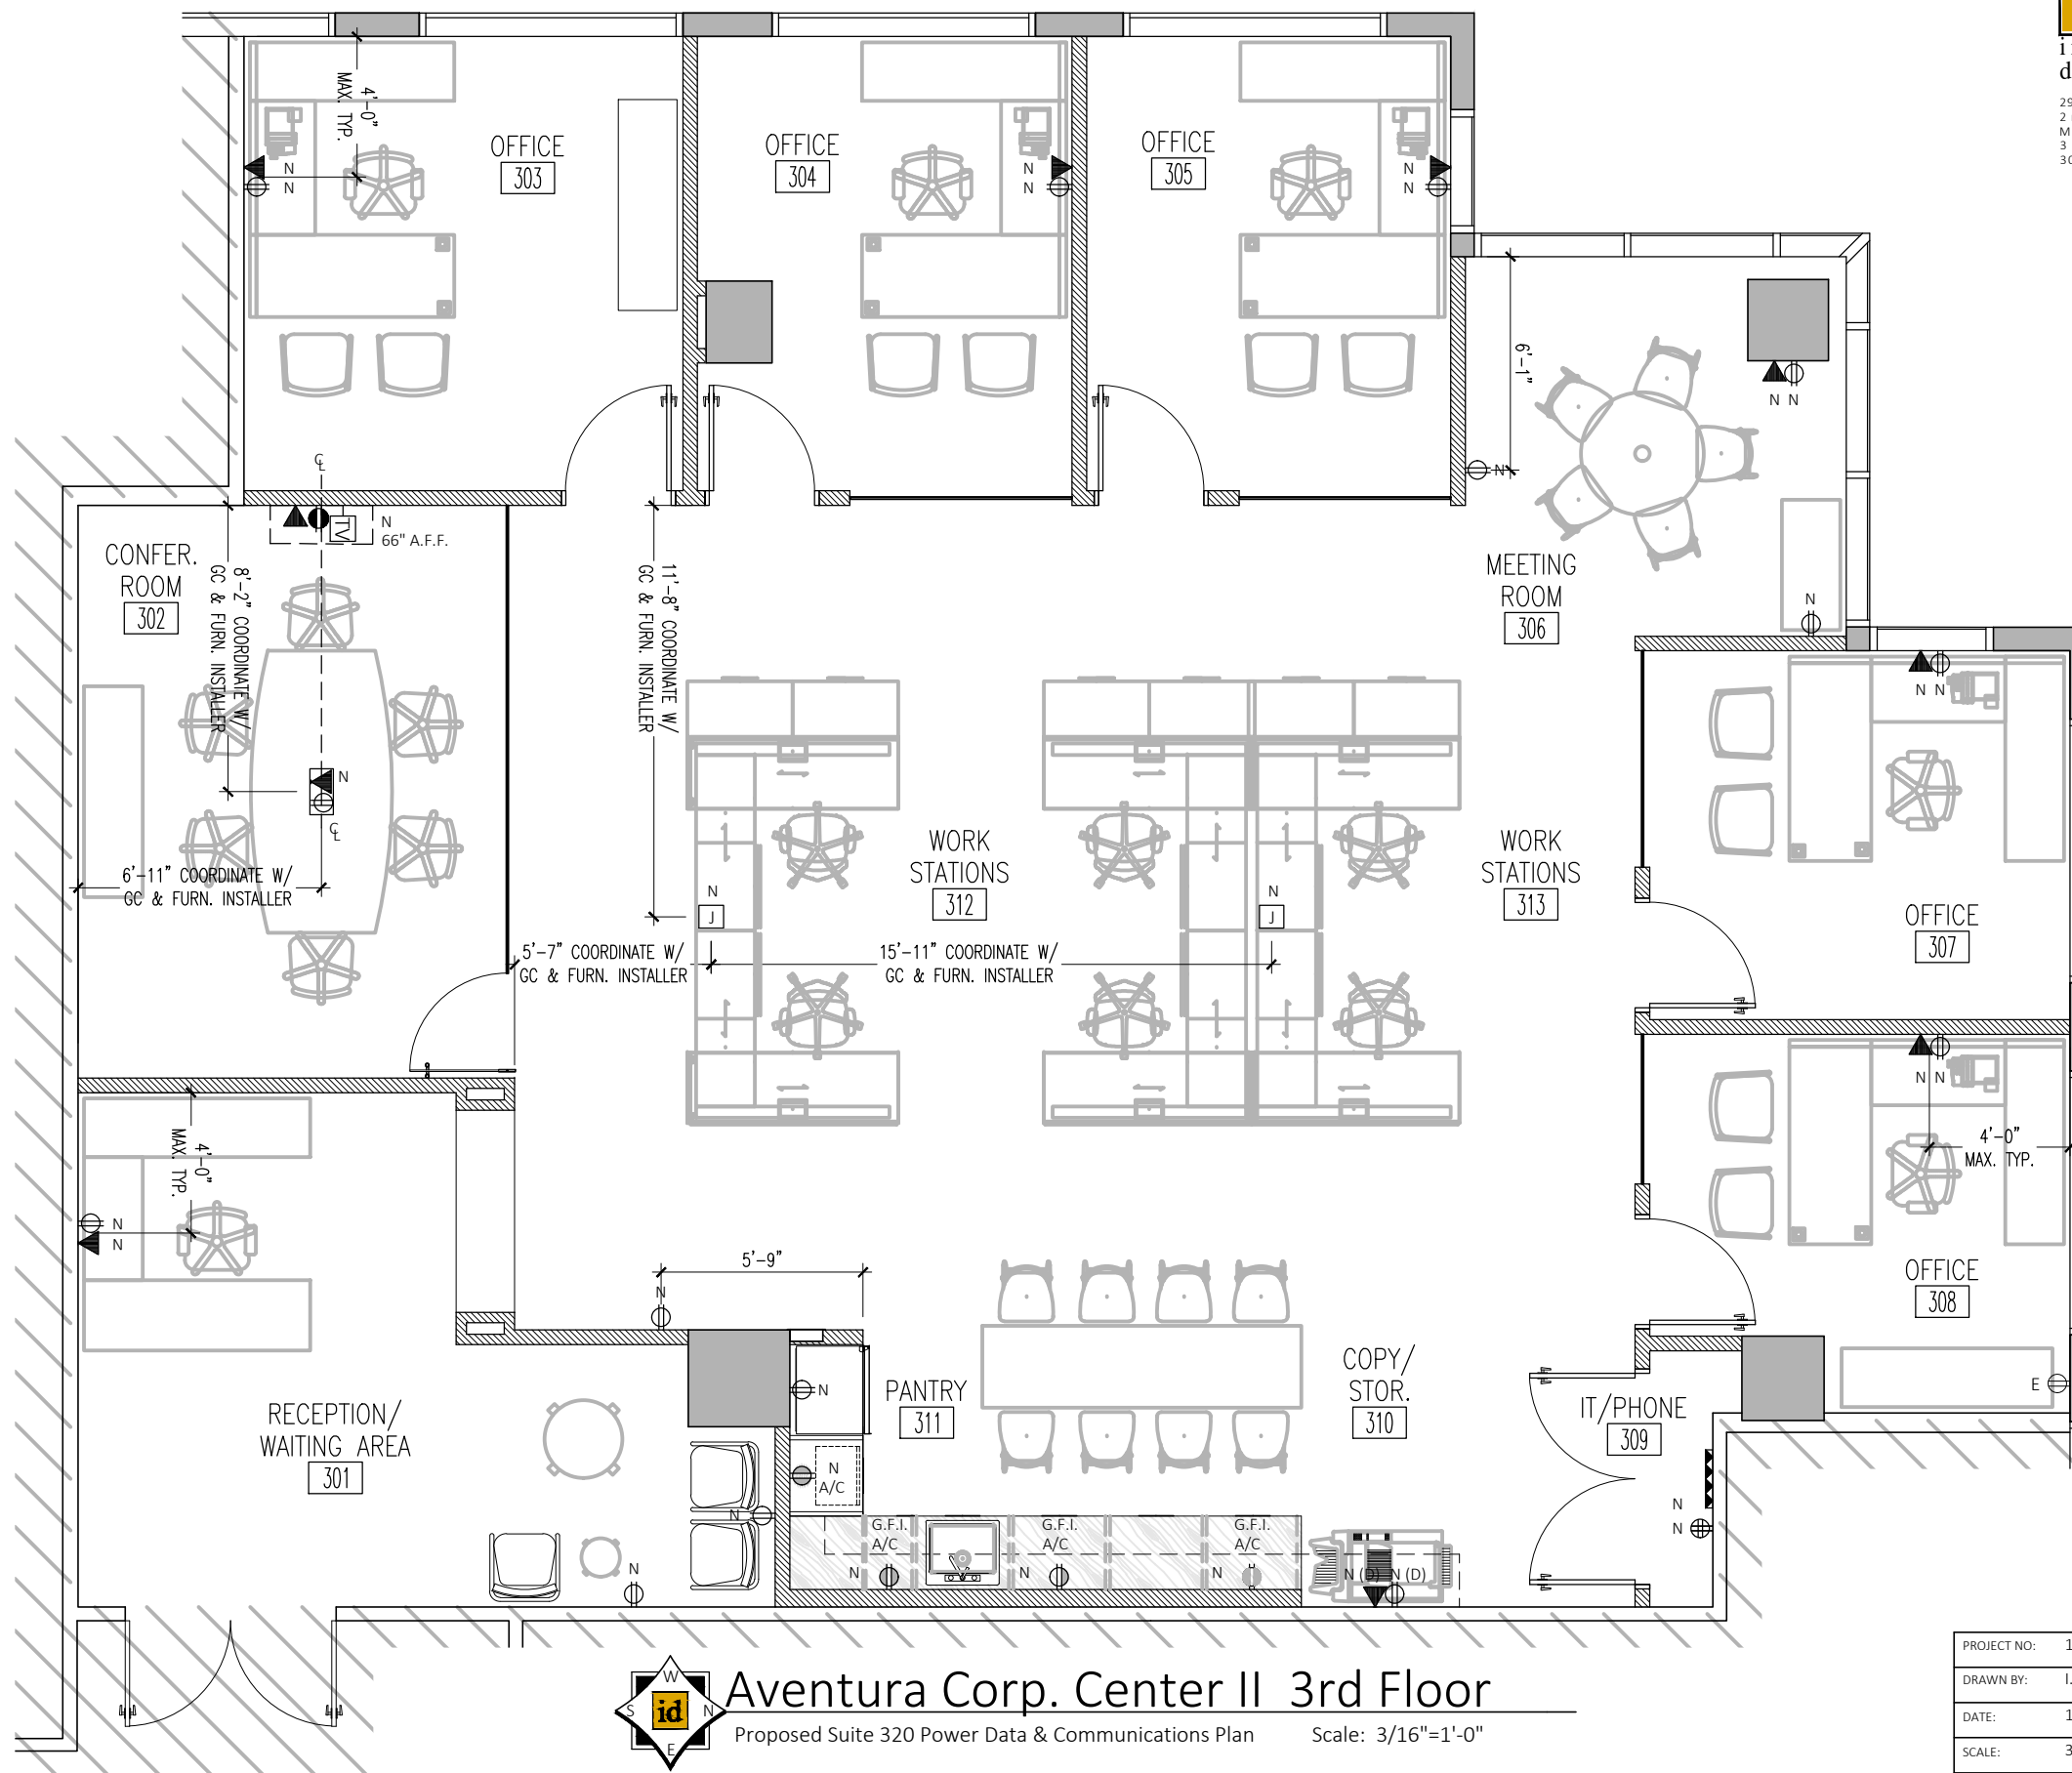

Aventura Corp. Center II 3rd Floor

Proposed Suite 320 Power Data & Communications Plan Scale: 3/16"=1'-0"

PROJECT NO:	1709-16
DRAWN BY:	I.M.
DATE:	12/12/2018
SCALE:	3/16"=1'-0"
SHEET NO:	SK-1

