




# Aventura Corp. Center 3rd Floor


Proposed Suite 370 Power Data & Communications Plan Scale: 3/16"=1'-0"

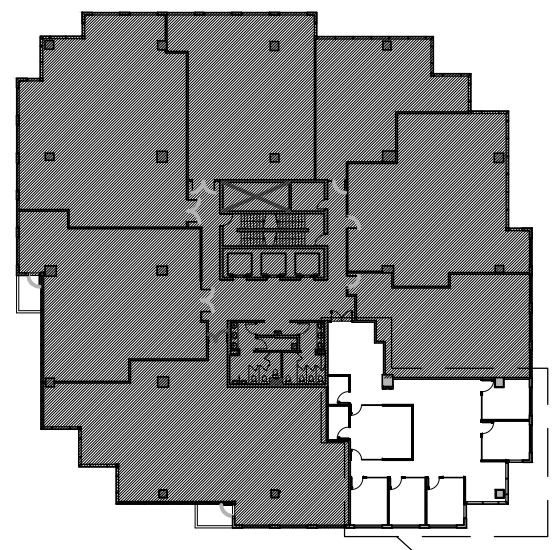

**KEY PLAN**  
N.T.S.

HATCHED AREA DENOTES NOT INCLUDED IN CONTRACT, OUTSIDE OF SCOPE OF WORK AND TO REMAIN UNCHANGED.

POWER AND COMMUNICATION LEGEND	
SYMBOL	DESCRIPTION
N	NEW DUPLEX OUTLET, 16" A.F.F.
N	NEW DUPLEX G.F.I. OUTLET, 40" A.F.F.
E	EXISTING DUPLEX, 16" A.F.F.
N	NEW QUAD OUTLET, 16" A.F.F. & 40" A.F.F., U.N.O.
N	NEW VOICE / DATA OUTLET, 16 A.F.F.
E	EXISTING VOICE / DATA OUTLET
N	NEW FLOOR MOUNTED POWER/DATA/TELEPHONE PORT AT CONFERENCE ROOM
N	NEW TELEPHONE BOARD OVER FIRE RATED PLYWOOD
<b>ABBREVIATIONS:</b> (A.F.F.) ABOVE FINISH FLOOR (D) DEDICATED OUTLET G.F.I. GROUND FAULT INTERRUPTOR (AC) ABOVE COUNTER N.I.C. NOT IN CONTRACT TYP. TYPICAL F.E.C. FIRE EXTINGUISHER CABINET	

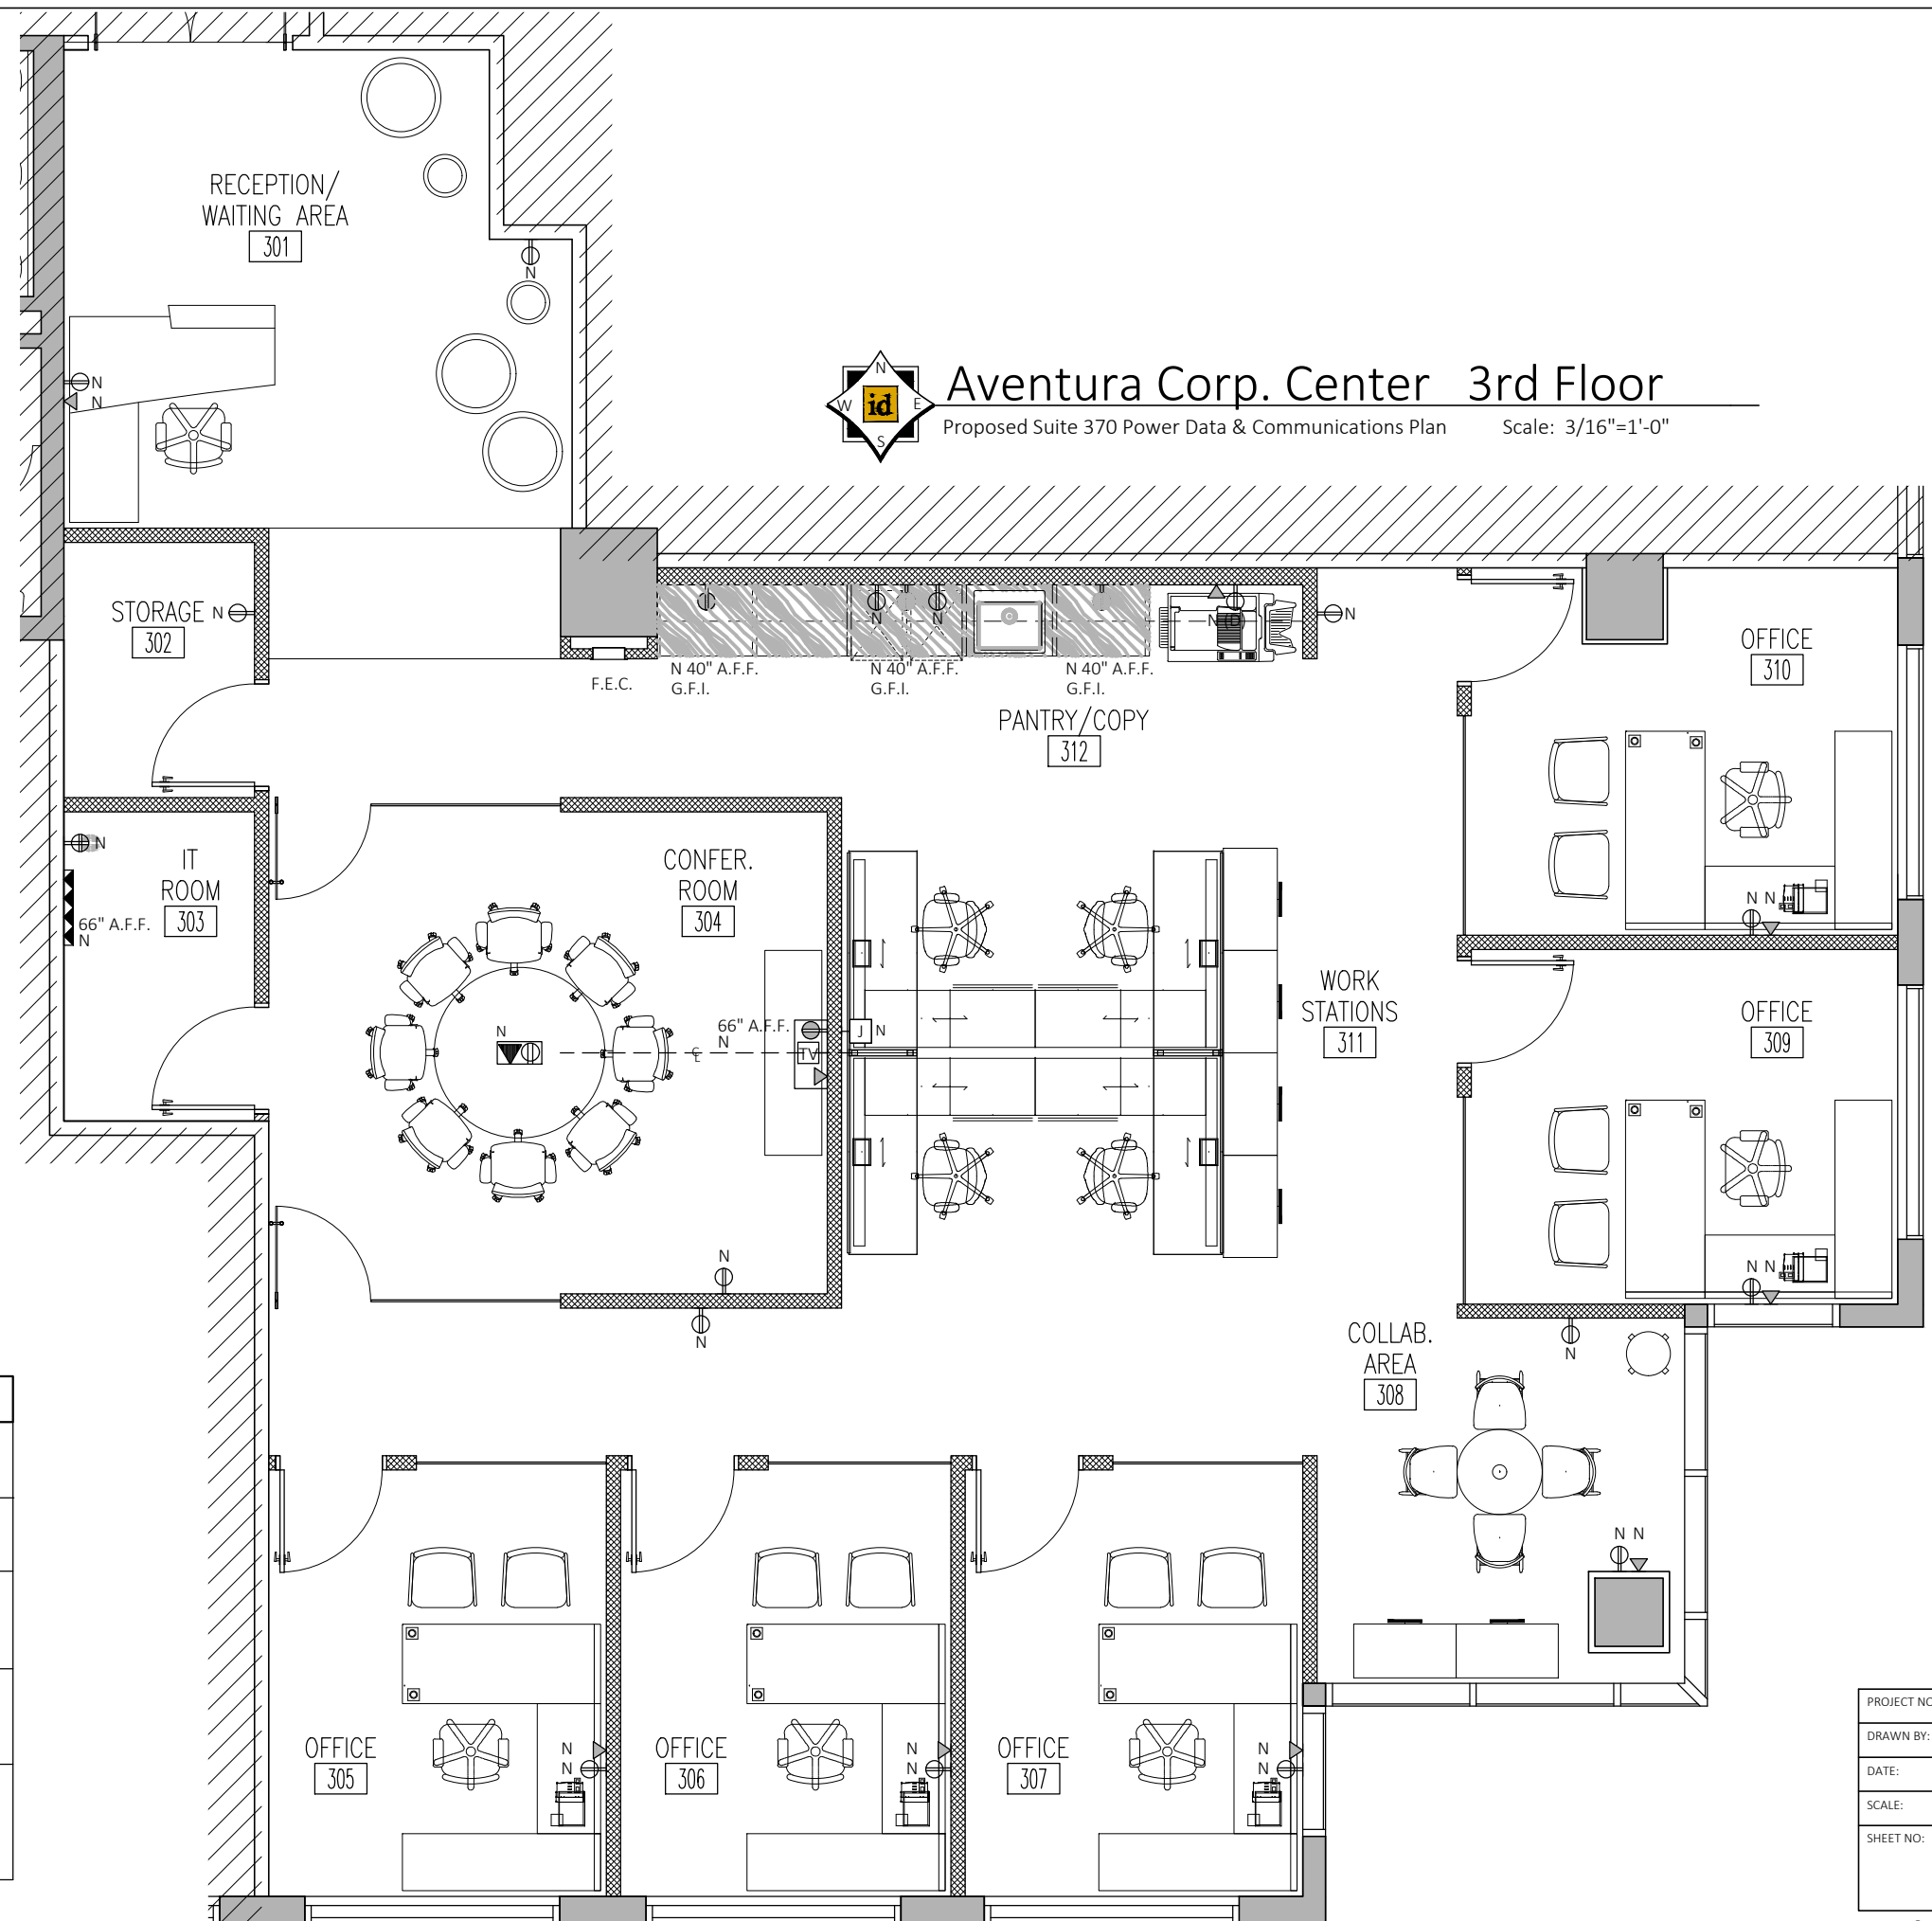

ARCHITECTURAL LEGEND	
	EXISTING WALL/STRUCTURE/NON-LOAD BEARING DEMISING WALL TO REMAIN, U.N.O.
	NEW NON-LOAD BEARING DEMISING WALL PARTITION, FULL HEIGHT TO UNDERSIDE OF DECK
	EXISTING STRUCTURE/COLUMN TO REMAIN
	HATCHED AREA DENOTES NOT INCLUDED IN CONTRACT, OUTSIDE OF SCOPE OF WORK
<b>ROOM NAME</b> 000	DENOTES ROOM NAME AND NUMBER

PROJECT NO:	1709-09-01
DRAWN BY:	I.M.
DATE:	12/11/2018
SCALE:	3/16"=1'-0"
SHEET NO:	SK-1

